

BUIL

ROOM NAME
###

GENERAL NOTES

 
PLAN NOTES

BUILDING CODE ANALYSIS DATA

DRAWING LIST

PLAN STATUS



**3300 Dakota Drive
Lot 23, Block C
STARDUST RANCH
NORTHLAKE, TX**



DESIGN	DRAWN	CHKD
--------	-------	------

SCALE:

 A-001

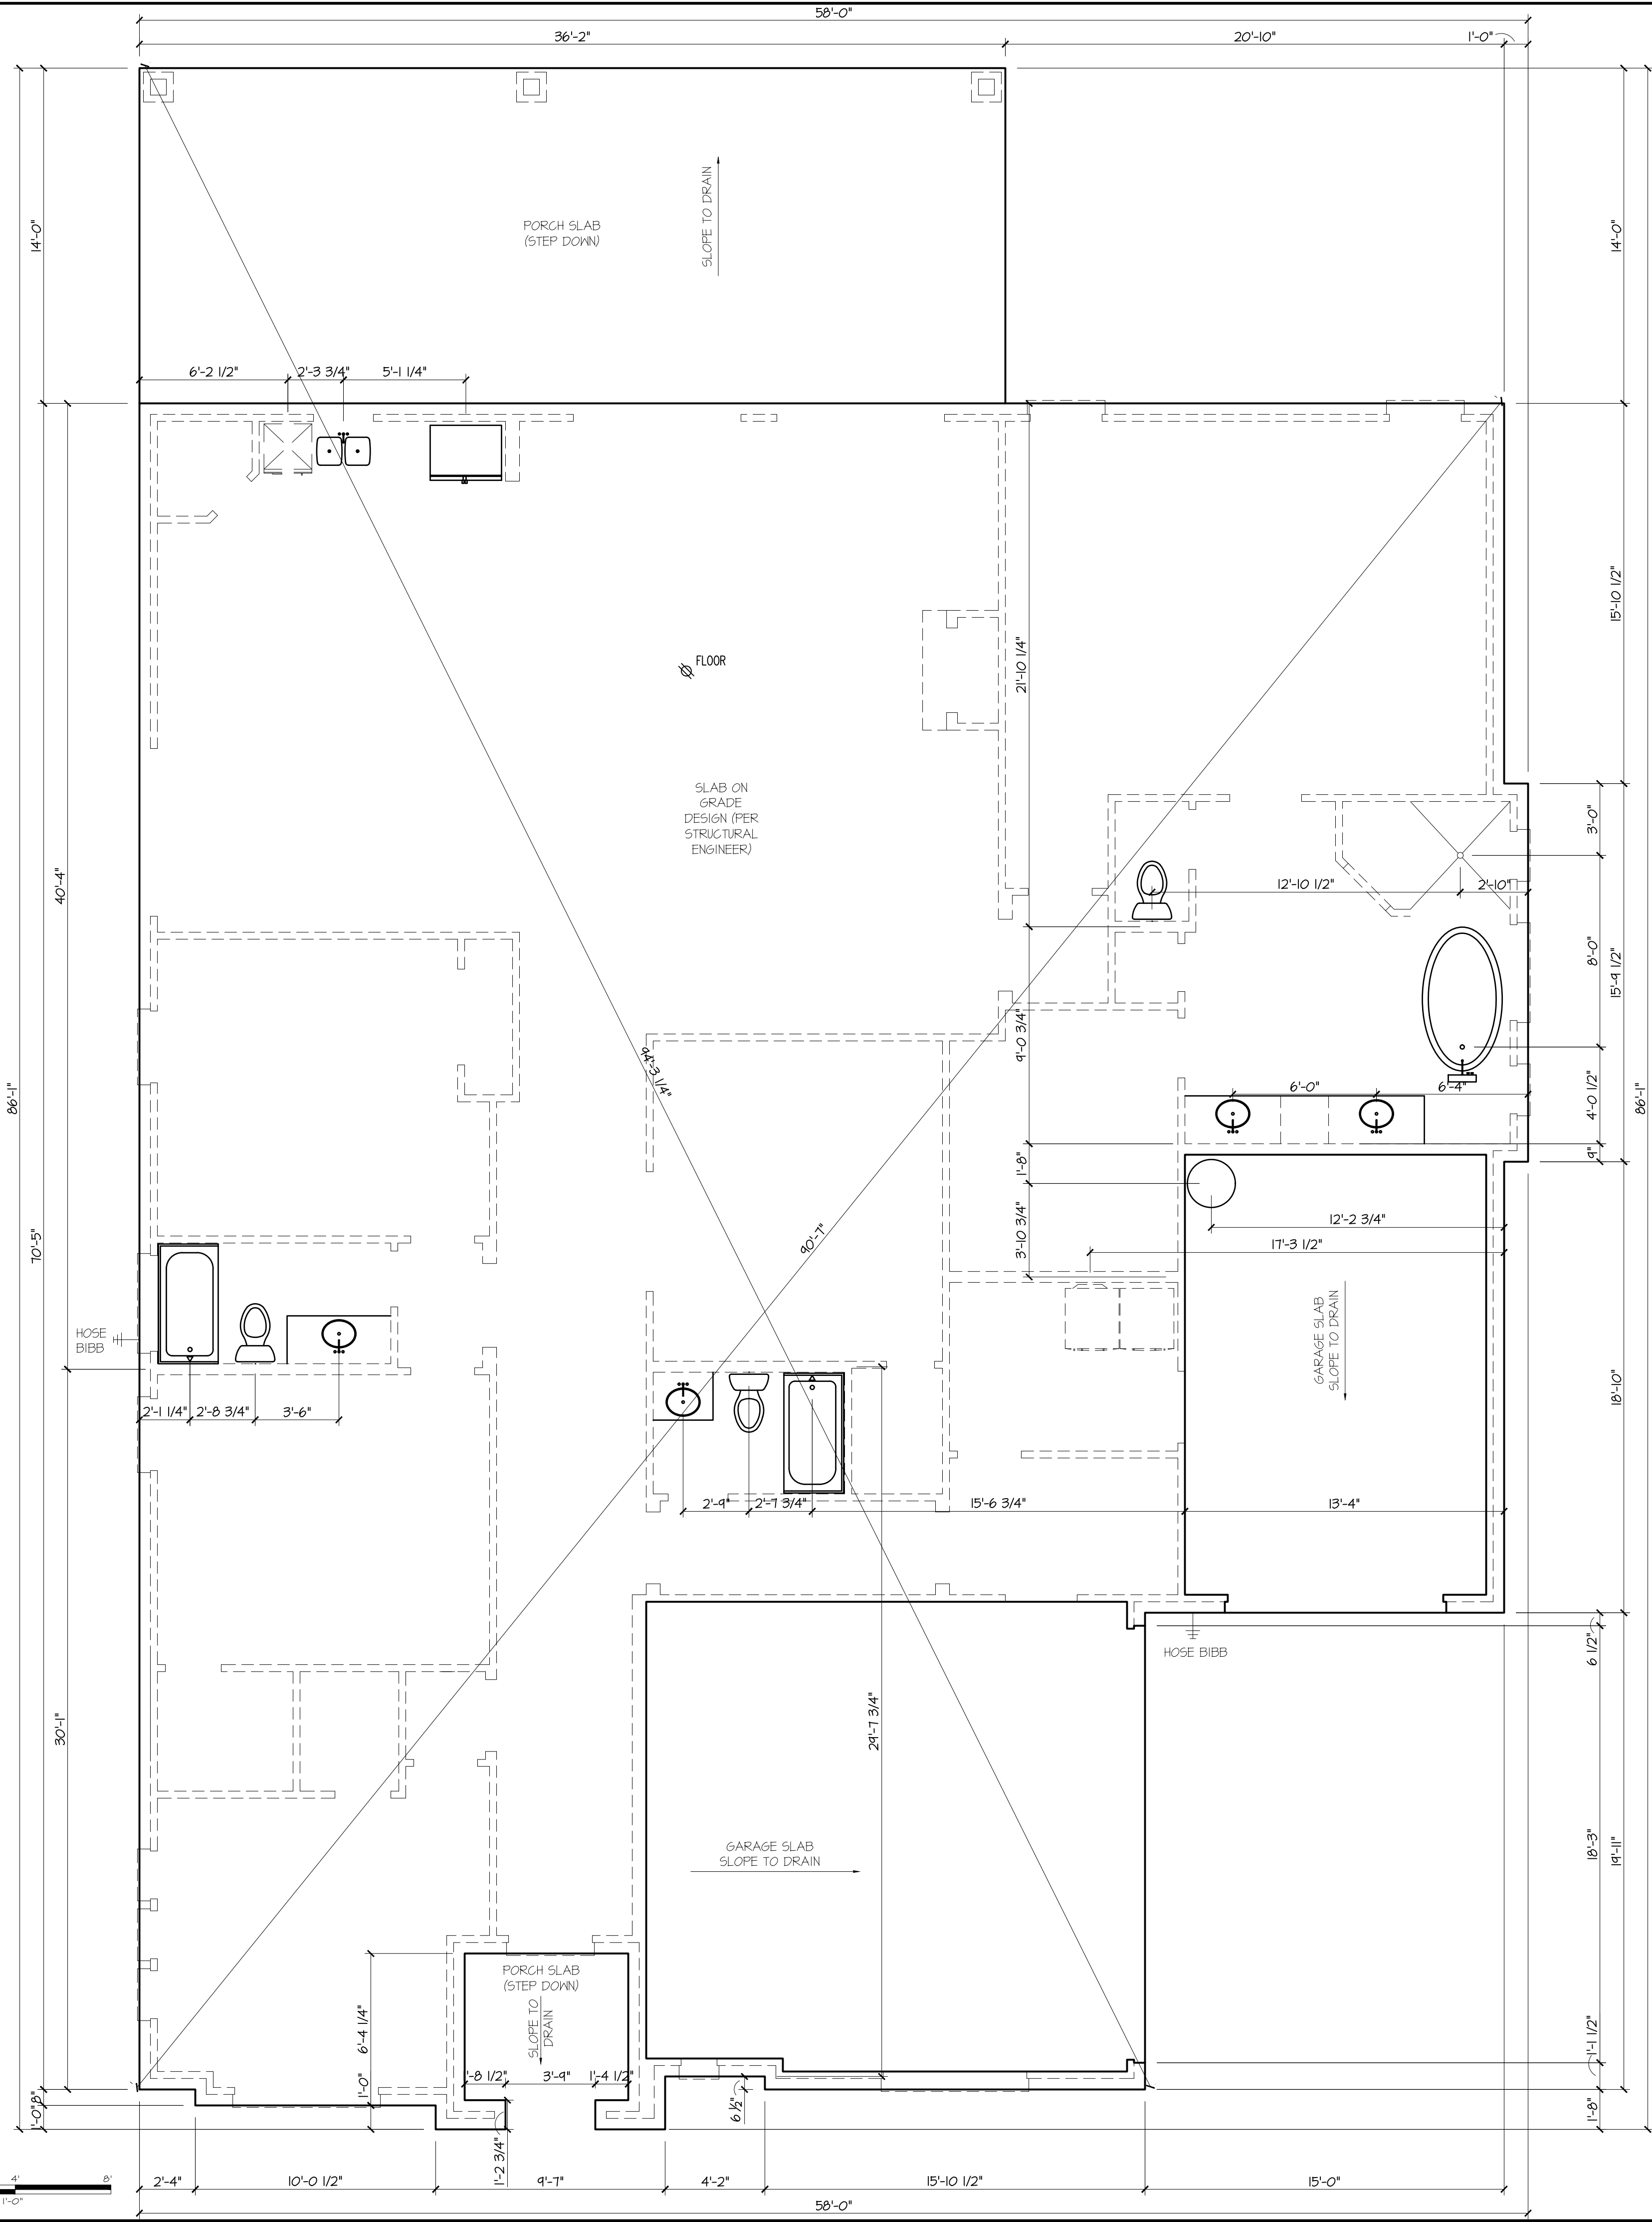


FOUNDATION DIMENSION CONTROL

SCALE: 1/4" = 1'-0"

DESIGN	DRAWN	CHKD
RC	MP	MP
SCALE:		
JOB No.	S2547.2020.05	
DATE:	2020.02.15	

3300 Dakota Drive
Lot 23, Block C
STARDUST RANCH
NORTHLAKE, TX

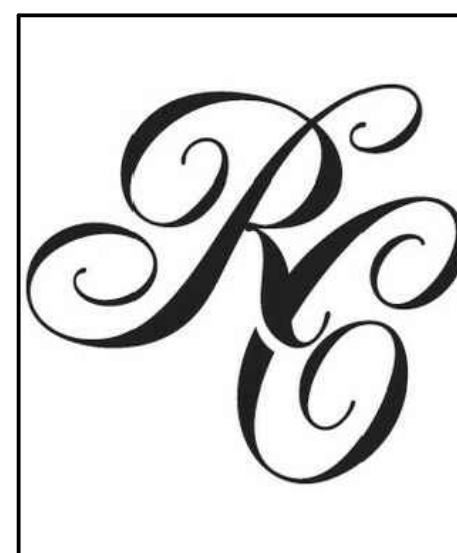



PLAN STATUS		
REV.	DATE	CHANGE
-	02.16.2021	ISSUE FOR REVIEW
-		

A-100

3300 Dakota Drive
16-Feb-21

DOORS				
All doors that are 8'-0" in height to have (4) hinges				
DESIGNATION	SIZE	TYPE	QUANTITY	COMMENT
1	3880	ENTRY	1	IRON DOOR
2	(2)3680	EXT. FULL LIGHT	2	FULL LITE FRENCH DOORS
3	3080	METAL/20 MIN.	2	GARAGE TO HOUSE
4	9080	OHD	1	
5	18080	OHD	1	
6	(2)1680	SC	1	
7	(2)2680	BARN	1	
8	2080	SC	3	
9	(2)2080	SC	1	
10	2480	SC	3	
11	2680	SC	3	
12	2880	SC	5	


WINDOWS				
Refer to Elevations for Window Head Heights				
DESIGNATION	SIZE	TYPE	QUANTITY	COMMENT
A	1640	FIXED	1	
B		NOT USED	0	
C		NOT USED	0	
D	2020	FIXED	5	
E	3056	SINGLE HUNG	2	
F	(2)3060	SINGLE HUNG	1	
G	3066	SINGLE HUNG	2	
H	2640	SINGLE HUNG	1	
J	4013	TRANS	1	OBSCURE GLASS / TEMPERED
K	4060	PICTURE	1	OBSCURE GLASS / TEMPERED
L	(2)3660	SINGLE HUNG	1	
M		NOT USED	0	
N		NOT USED	0	

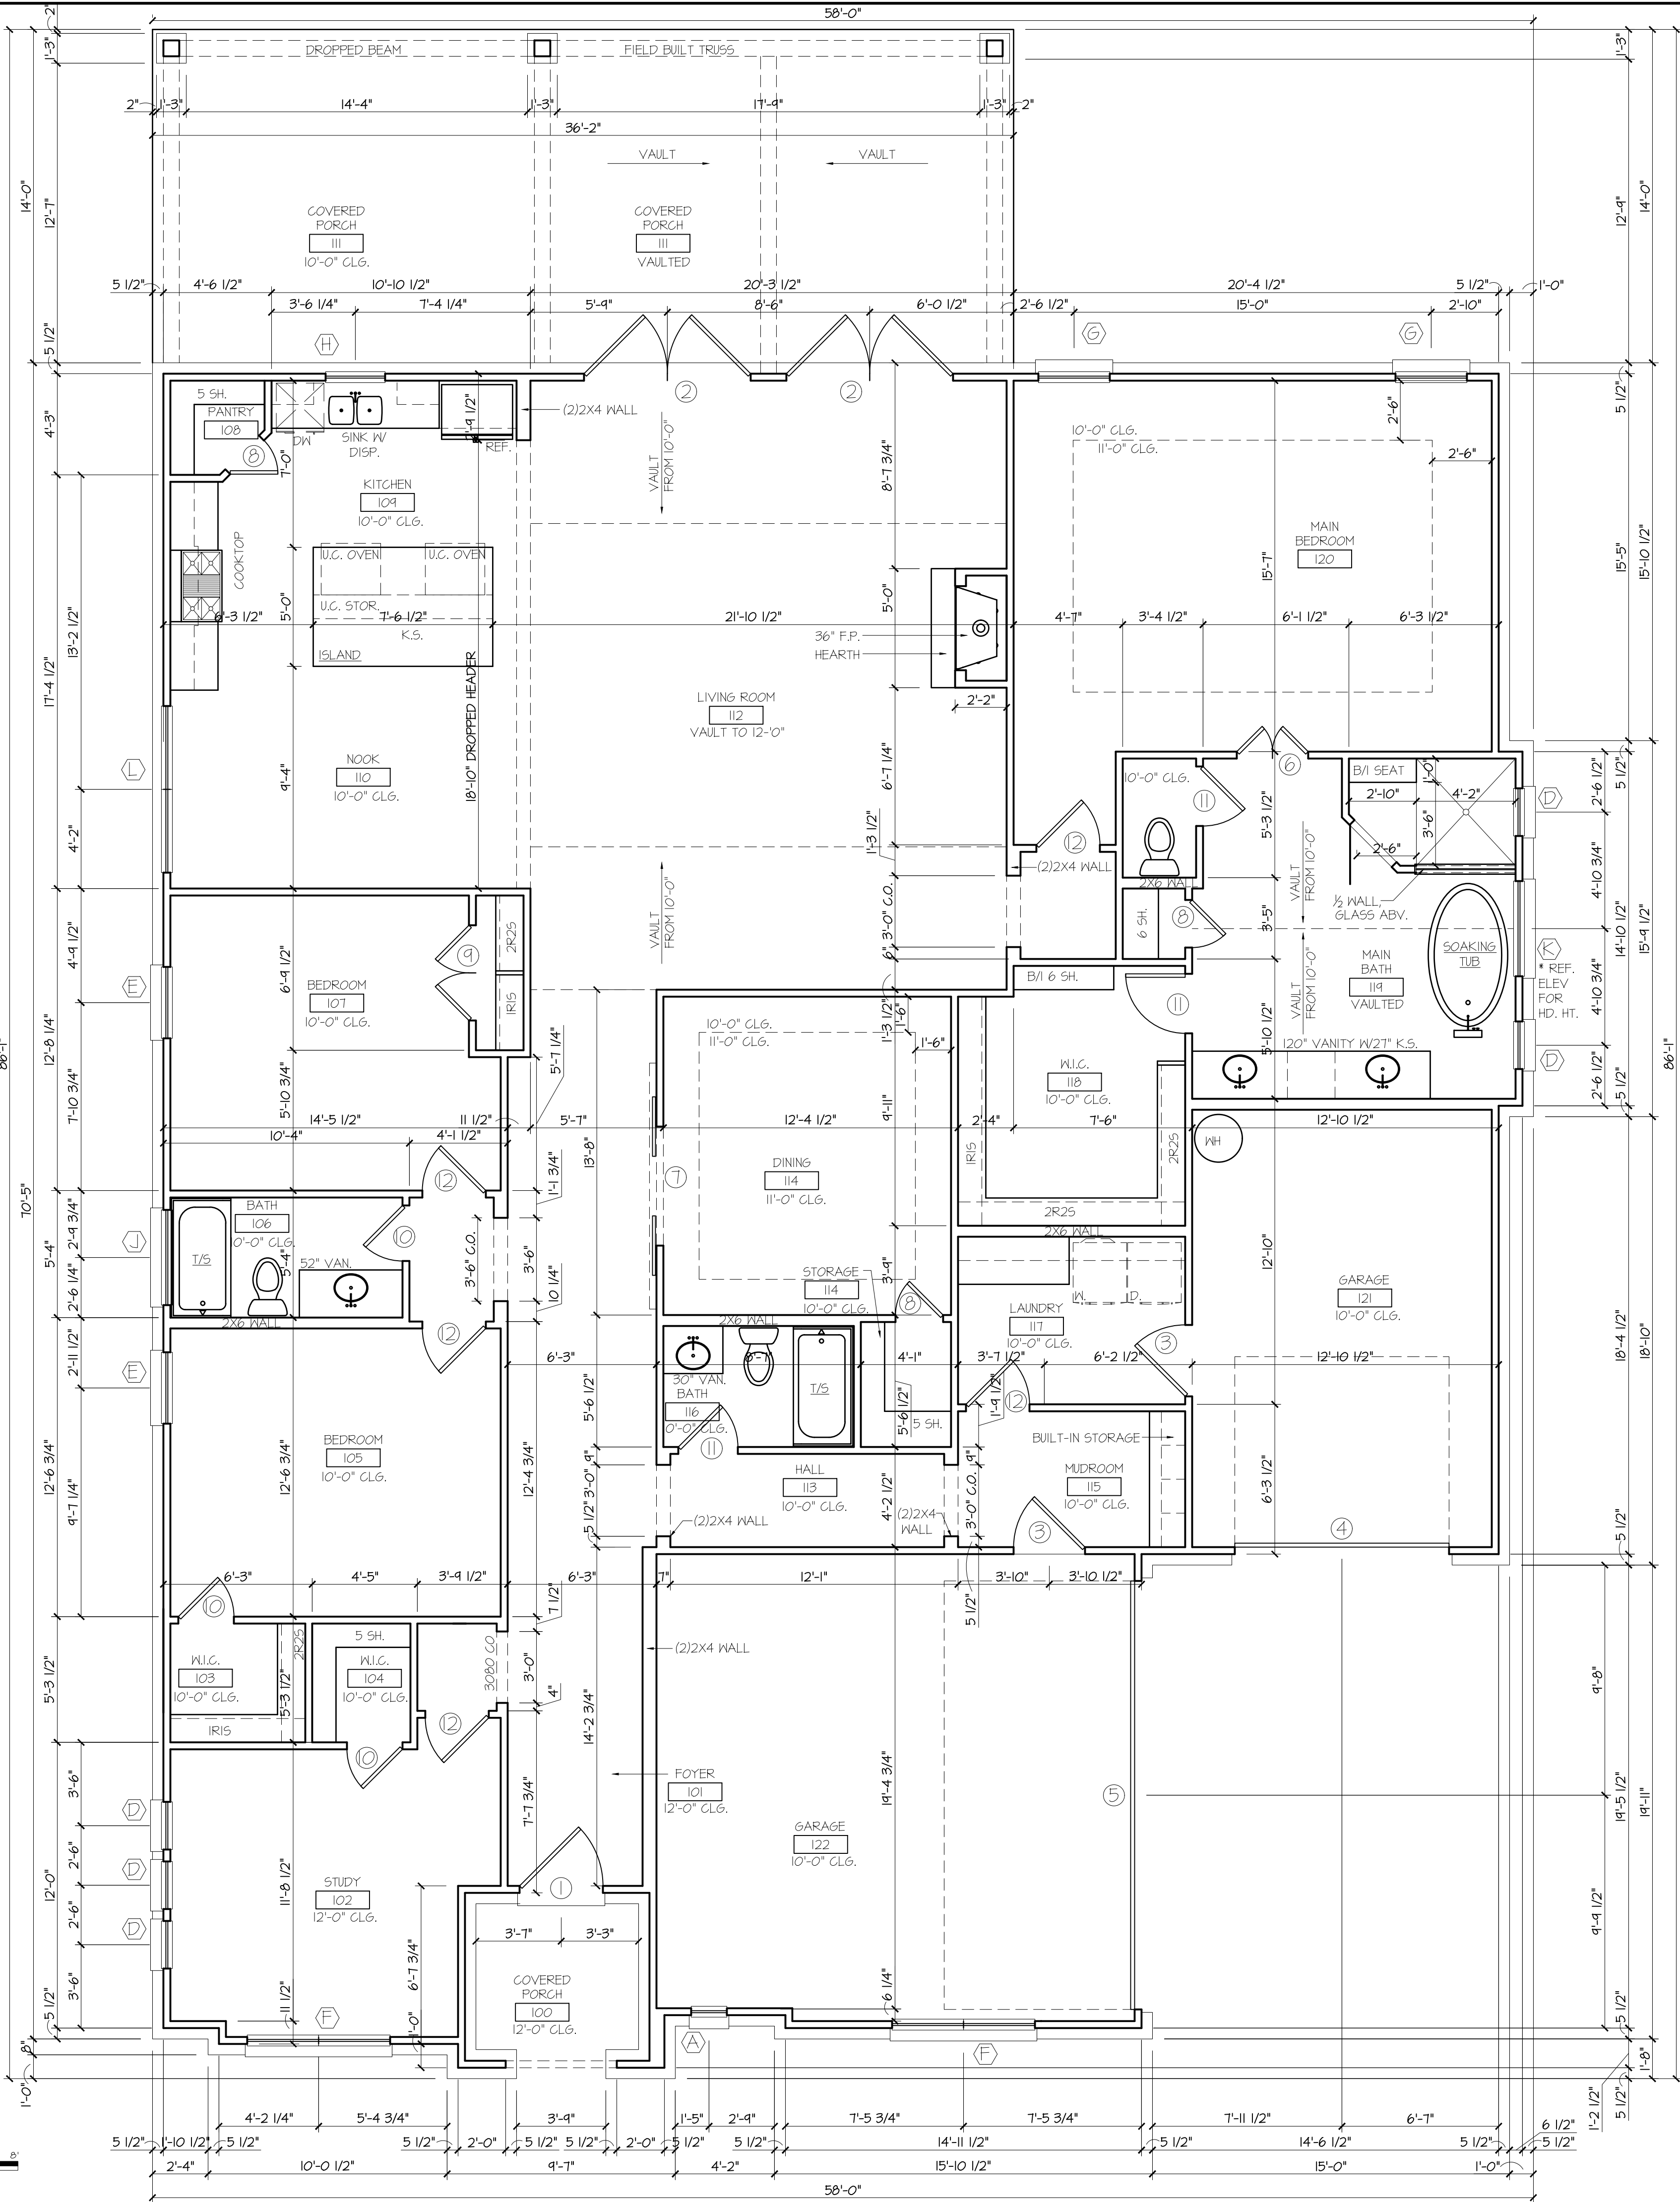 

1 FIRST FLOOR PLAN
SCALE: 1/4" = 1'-0"

PLAN STATUS					
REV.	DATE	CHANGE	BY		
-	02.16.2021	ISSUE FOR REVIEW	MP		
-					

 3300 Dakota Drive
Lot 23, Block C
STARDUST RANCH
NORTHLAKE, TX



DESIGN	DRAWN	CHKD
RC	MP	MP
SCALE:		
JOB No.	S2547.2020.05	
DATE:	2020.02.15	
A-101		

DESIGN	DRAWN	CHKD
RC	MP	MP
SCALE:		
JOB No.	S2547.2020.05	
DATE:	2020.02.15	
A-102		



2 LEFT ELEVATION
SCALE: 1/4" = 1'-0"




1 FRONT ELEVATION
SCALE: 1/4" = 1'-0"

PLAN STATUS			BY
REV.	DATE	CHANGE	MP
-	02.16.2021	ISSUE FOR REVIEW	
-			
-			
-			

3300 Dakota Drive
Lot 23, Block C
STARDUST RANCH
NORTHLAKE, TX




DESIGN	DRAWN	CHKD
RC	MP	MP
SCALE:		
JOB No.	S2547.2020.05	
DATE:	2020.02.15	

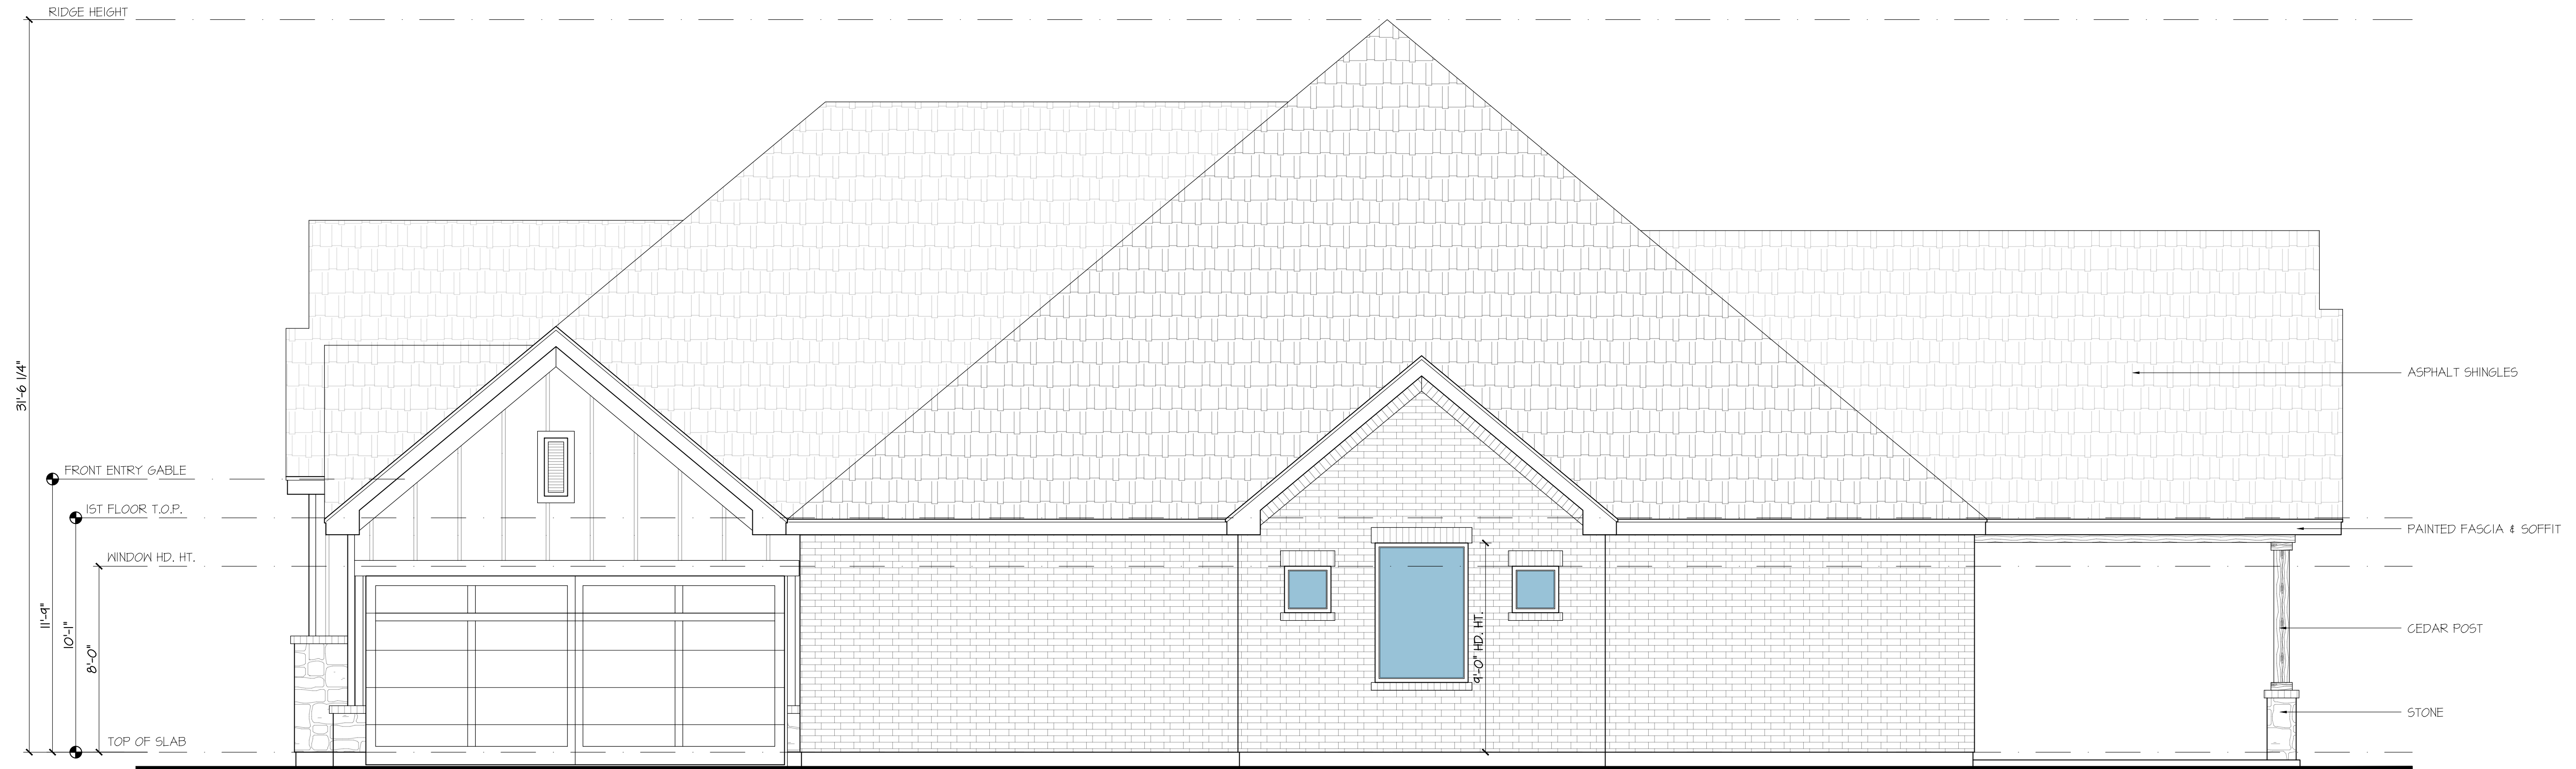

2 RIGHT ELEVATION
SCALE: 1/4" = 1'-0"



 1 REAR ELEVATION
SCALE: 1/4" = 1'-0"



PLAN STATUS			BY
REV.	DATE	CHANGE	MP
-	02.16.2021	ISSUE FOR REVIEW	
1			

3300 Dakota Drive
Lot 23, Block C
STARDUST RANCH
NORTH LAKE, TX




DESIGN	DRAWN	CHKD
RC	MP	MP
SCALE:		
JOB No.	S2547.2020.05	
DATE:	2020.02.15	

A-202

ELECTRICAL LEGEND	
SYMBOL	DESCRIPTION
	RECESSED CAN
	CHANDELIER
	PENDANT LIGHT
	SURFACE MOUNTED LIGHT
	BATH LIGHT / EXHAUST FAN COMBO
	EXHAUST FAN (200 CFM MIN.)
	BATH VANITY LIGHT
	EXTERIOR CARRIAGE LAMP
	EXTERIOR UP LIGHTS
	EXTERIOR TWIN MOUNTED FLOOD LIGHT
	SURFACE MOUNT 4 X 12 LED
	UNDER COUNTER LED STRIPS
	4" DIRECTIONAL RECESSED LIGHT
	SURFACE MOUNT 8 X 48 LED
	CEILING FAN, NO LIGHT KIT
	DUPLEX OUTLET
	GROUND FAULT CIRCUIT INTERRUPT
	GROUND FAULT CIRCUIT INTERRUPT
	EXT. WATERPROOF GROUND FAULT CIRCUIT INTERRUPT
	SWITCH
	CARBON MONOXIDE/SMOKE DETECTOR
	SMOKE DETECTOR

0 2' 4' 8'
Scale: 1/4" = 1'-0"

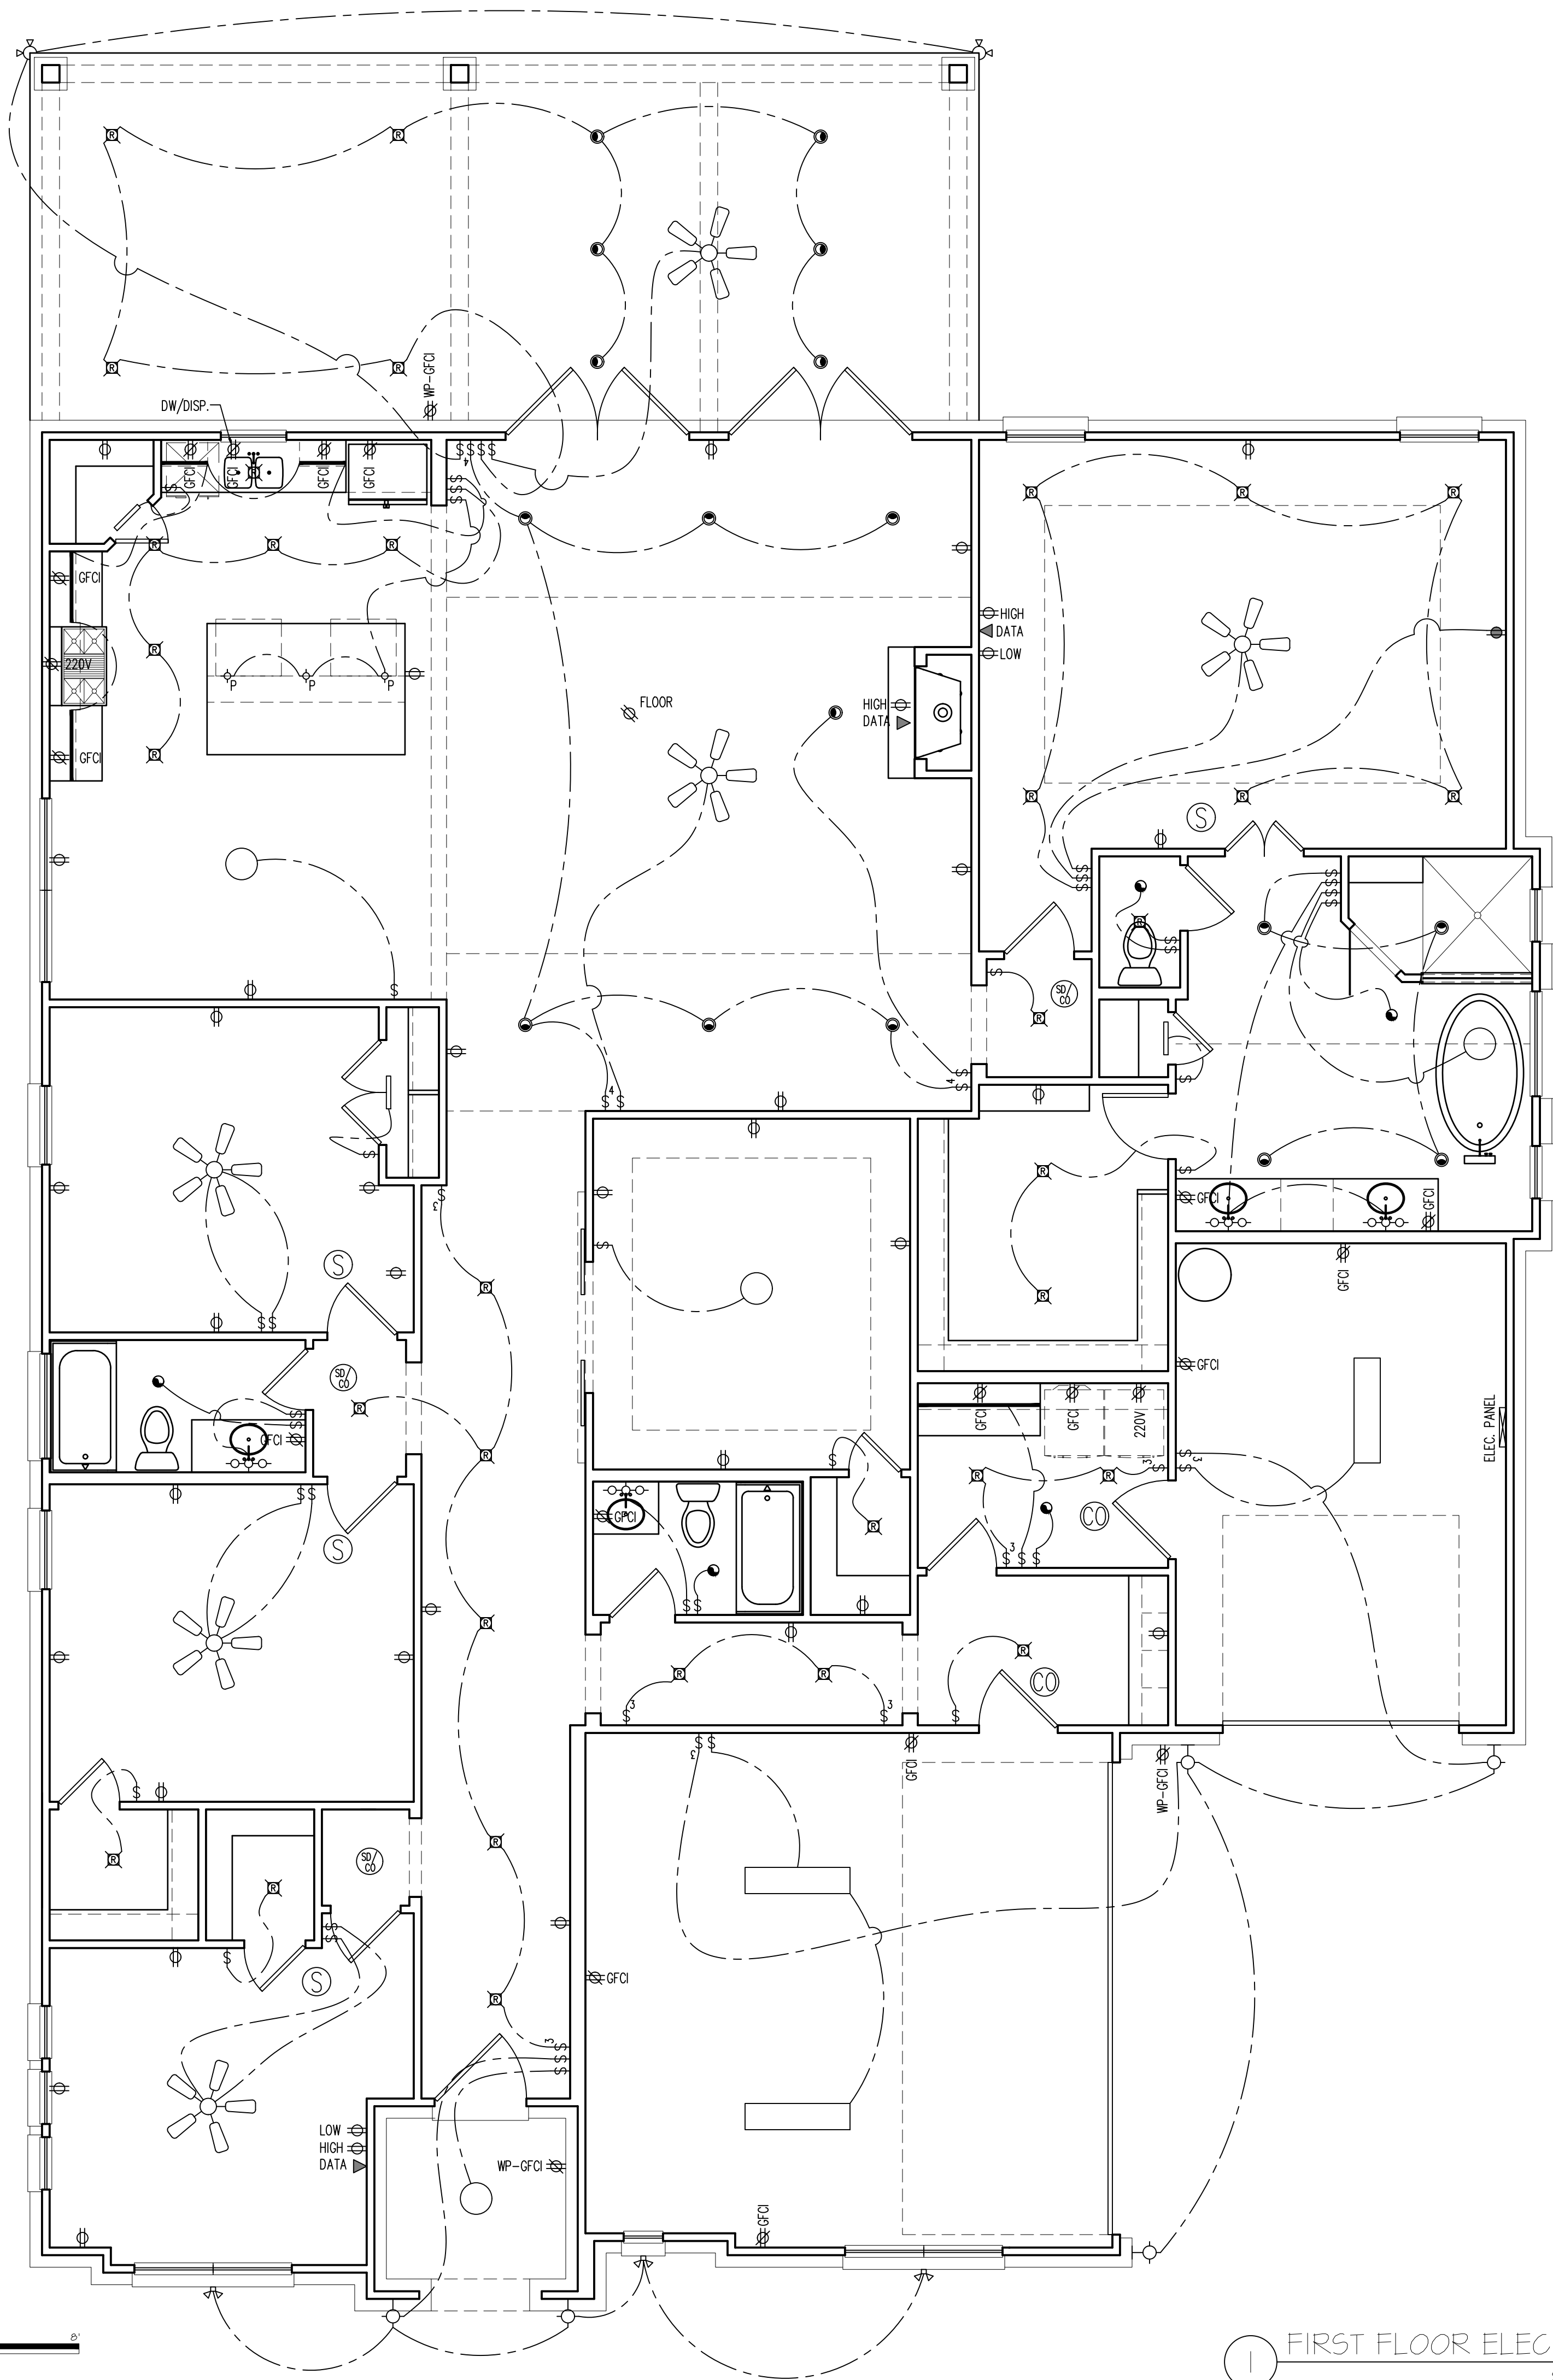

1 FIRST FLOOR ELEC. PLAN
SCALE: 1/4" = 1'-0"

3300 Dakota Drive
Lot 23, Block C
STARDUST RANCH
NORTHLAKE, TX



DESIGN	DRAWN	CHKD
RC	MP	MP
SCALE:		
JOB No.	S2547.2020.05	
DATE:	2020.02.15	

E-100

PLAN STATUS		
REV.	DATE	BY
-	02.16.2021	MP
-	ISSUE FOR REVIEW	
-		
-		
-		